



- NOTES:**
1. PIPE LOCATIONS ARE ADOPTED FROM CITY OF FORTUNA WATER SYSTEM MAP AND CITY STAFF VERIFICATION
  2. ALL PIPE LOCATIONS ARE APPROXIMATE

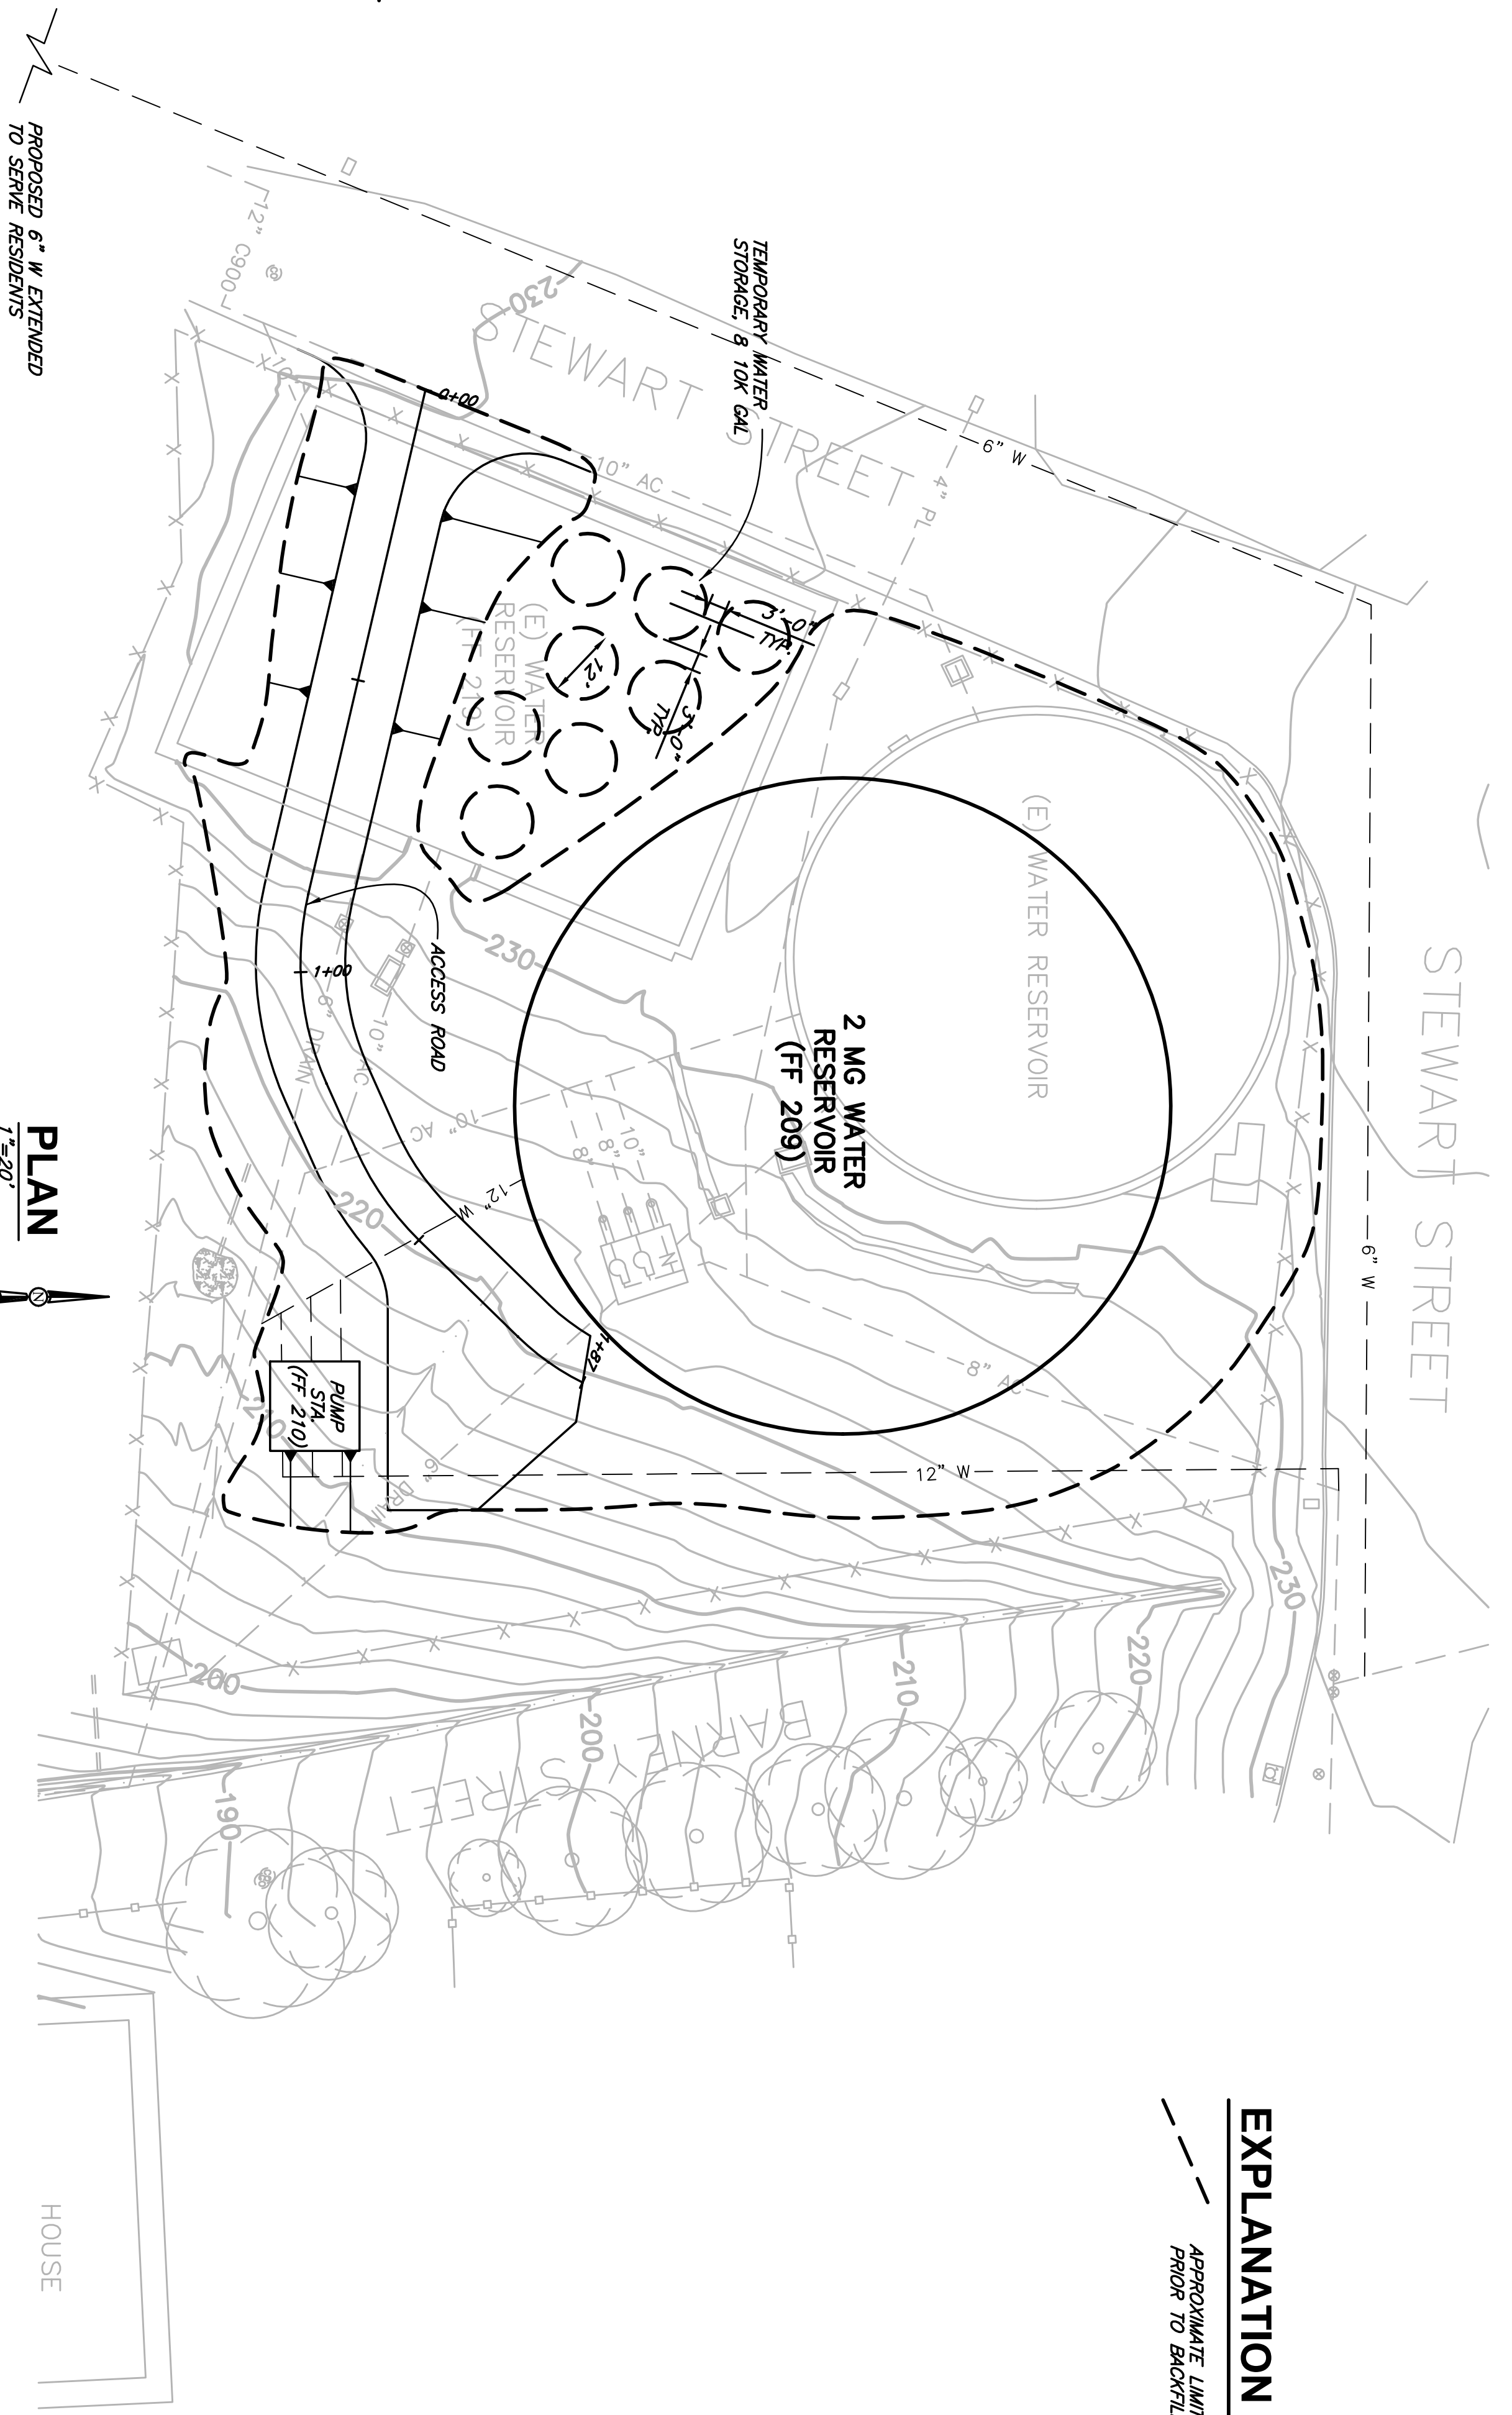

**EXPLANATION**  
 --- APPROXIMATE LIMITS OF GRADING  
 --- PRIORITY BACKFILLING

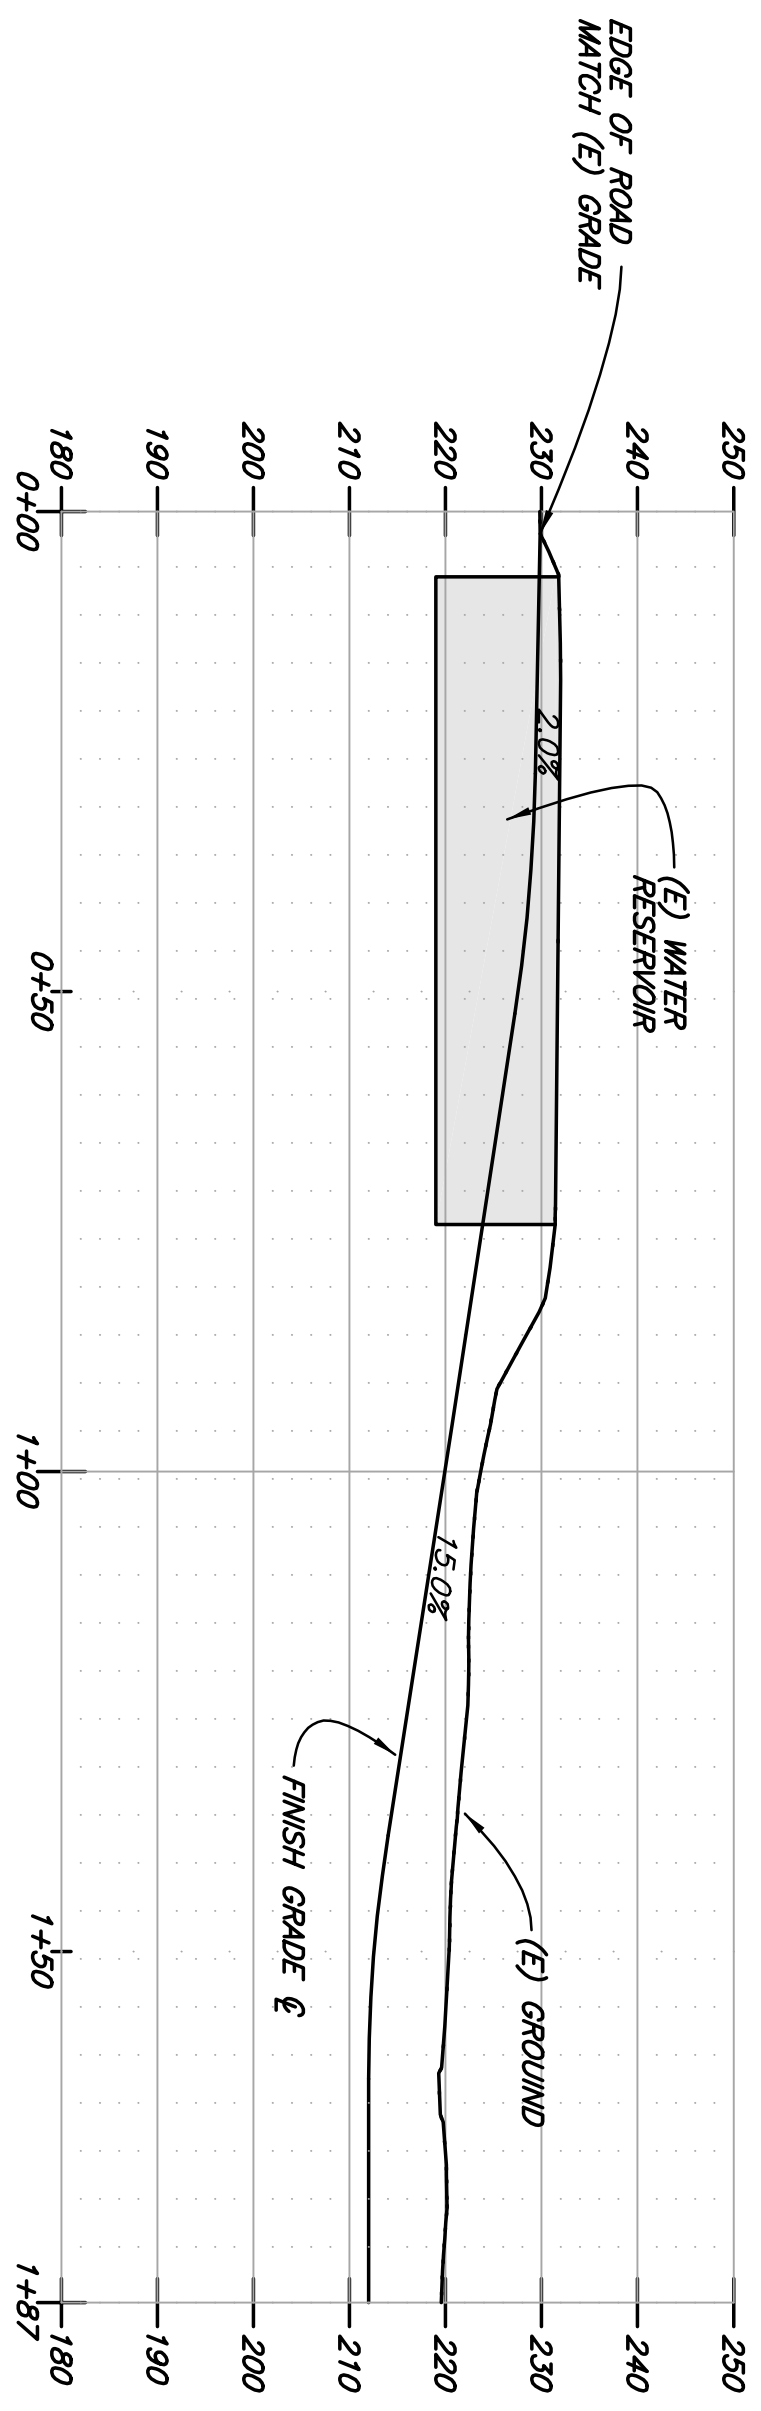

**ACCESS ROAD PROFILE**  
 V: 1"=20'  
 H: 1"=20'

DRAWING 1	CITY OF FORTUNA STEWART STREET RESERVOIRS REPLACEMENT FORTUNA, CALIFORNIA		DSGN BAF/RJ	NO.	DATE	REVISION	BY	 <b>CONSULTING ENGINEERS &amp; GEOLOGISTS, INC.</b> 812 W. Wabash Eureka, CA 95501 (707)441-8855 FAX (707)441-8877	VERIFY SCALES BAR IS ONE INCH ON ORIGINAL DRAWING
	PRELIMINARY SITE PLAN AND ACCESS ROAD PROFILE		DR DSL						0
	SHT 1		CHK BAF						1"
	DATE 5/2009		APVD						IF NOT ONE INCH ON THIS SHEET, ADJUST SCALES ACCORDINGLY
PROJ. NO. 009030									